

Statistics						
Description	Symbol	Avg	Max	Min	Max/Min	Avg/Min
EGRESS FRONT DOOR	✕	4.03 fc	7.11 fc	1.20 fc	5.9:1	3.4:1
EGRESS PATH	✕	1.30 fc	5.22 fc	0.19 fc	27.5:1	6.8:1
EGRESS SIDE EXIT	✕	3.18 fc	7.37 fc	0.64 fc	11.5:1	5.0:1

Schedule														
Symbol	Label	QTY	Manufacturer	Catalog Number	Description	Lamp	Number Lamps	Filename	Lumens per Lamp	LLF	Wattage	Efficiency	Distribution	Notes
☰	A1E	3	BEGA Converted by LUMCat V 25.10.2016 / H.R.	10W24 374-K3-COLOR	24 374 K4	LED 12.3W	1	24374K4_BEGA_IJS.ies	1077	0.9	14.1	100%		
⊗	CE	2	GREEN CREATIVE LTD	LFT4-80CCTS-D1- DIM010UNV- NCPLATE468	SLFT4-80CCTS/DIM010UNV	12 WAT LED	1	SLFT4-80CCTS- DIM010UNV_1- 0.IES	1031	0.9	11.98	100%		
▤	DE	6	ILP LTG	PAN22-20WLED-U-35K	PAN22-20WLED-U-40		1	PAN22-20WLED- U-40- G98_IJSNA200 2.IES	2484	0.88	16,2547	90%		
▥	EM	1	EVENLITE INV	PWII 250-LED-LC-FD- AA-UP-D1	250W 3 ZONE INV		1	ECBRM.ies	184	0.1	2.32	100%	DIRECT, SC- 0=1.29, SC- 90=1.3	
▧	EMC	7	EVENLITE	TCXCOM-RU-W-SD-D1	LED EMERGENCY COMBO		1	LHQM_LED.ies	Absolute	1	1.5	100%	DIRECT, SC- 0=0.43, SC- 90=0.5	
▨	EX	0	EVENLITE LTG	TLX-AC-RU-W-SD-D1	Low Profile, Emergency exit	LED	1	ECC_M12.ies	73	1	0.72	100%	DIRECT, SC- 0=1.19, SC- 90=0.23	


2	04-08-2021	REVISED PER ENGINEERS LETTER DATED 2-4-21.
1	10-1-2020	REVISED FOR COMPLETENESS
REV.	DATE	DESCRIPTION


TWO RIVER ENGINEERING
www.tworivereng.com
 P.O. Box 155 Tel: 732.866.0111
 Colts Neck, N.J. 07722 Fax: 732.866.4348


■ Civil Engineers
 ■ Forensic Experts
 ■ Environmental Consultants

PROJECT NO.: 19079
 DATE: APRIL 8, 2020
 DRAWING NO.: 19079-01A
 DRAWN BY: AJG
 CLIENT: PARK VALLEY
 SCALE: 1"=10'

LIGHTING PLAN
"PARK VALLEY DEVELOPMENT"
PRELIMINARY & FINAL
MAJOR SITE PLAN
 OF
BLOCK 33
LOT 9.01
 TAX MAP SHEET NO. 2
 BOROUGH OF RED BANK
 MONMOUTH COUNTY
 NEW JERSEY


A.J. GARITO, JR.
 DATE
 04-08-21
 N.J. Professional Engineer
 License No. 24GE03799700

SHEET NO. 5 OF 8

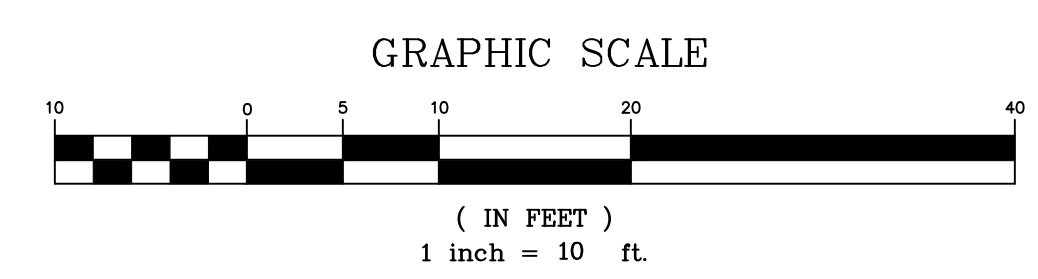

COPYRIGHT © 2020, TWO RIVER ENGINEERING - ALL RIGHTS RESERVED.
 THE CONTENTS OF THIS DRAWING ARE THE PROPERTY OF TWO RIVER ENGINEERING, INC. NO PART OF THIS DRAWING IS TO BE REPRODUCED OR TRANSMITTED IN ANY FORM OR BY ANY MEANS, ELECTRONIC OR MECHANICAL, INCLUDING PHOTOCOPYING, RECORDING, OR BY ANY INFORMATION STORAGE AND RETRIEVAL SYSTEM, WITHOUT THE WRITTEN PERMISSION OF TWO RIVER ENGINEERING, INC.